


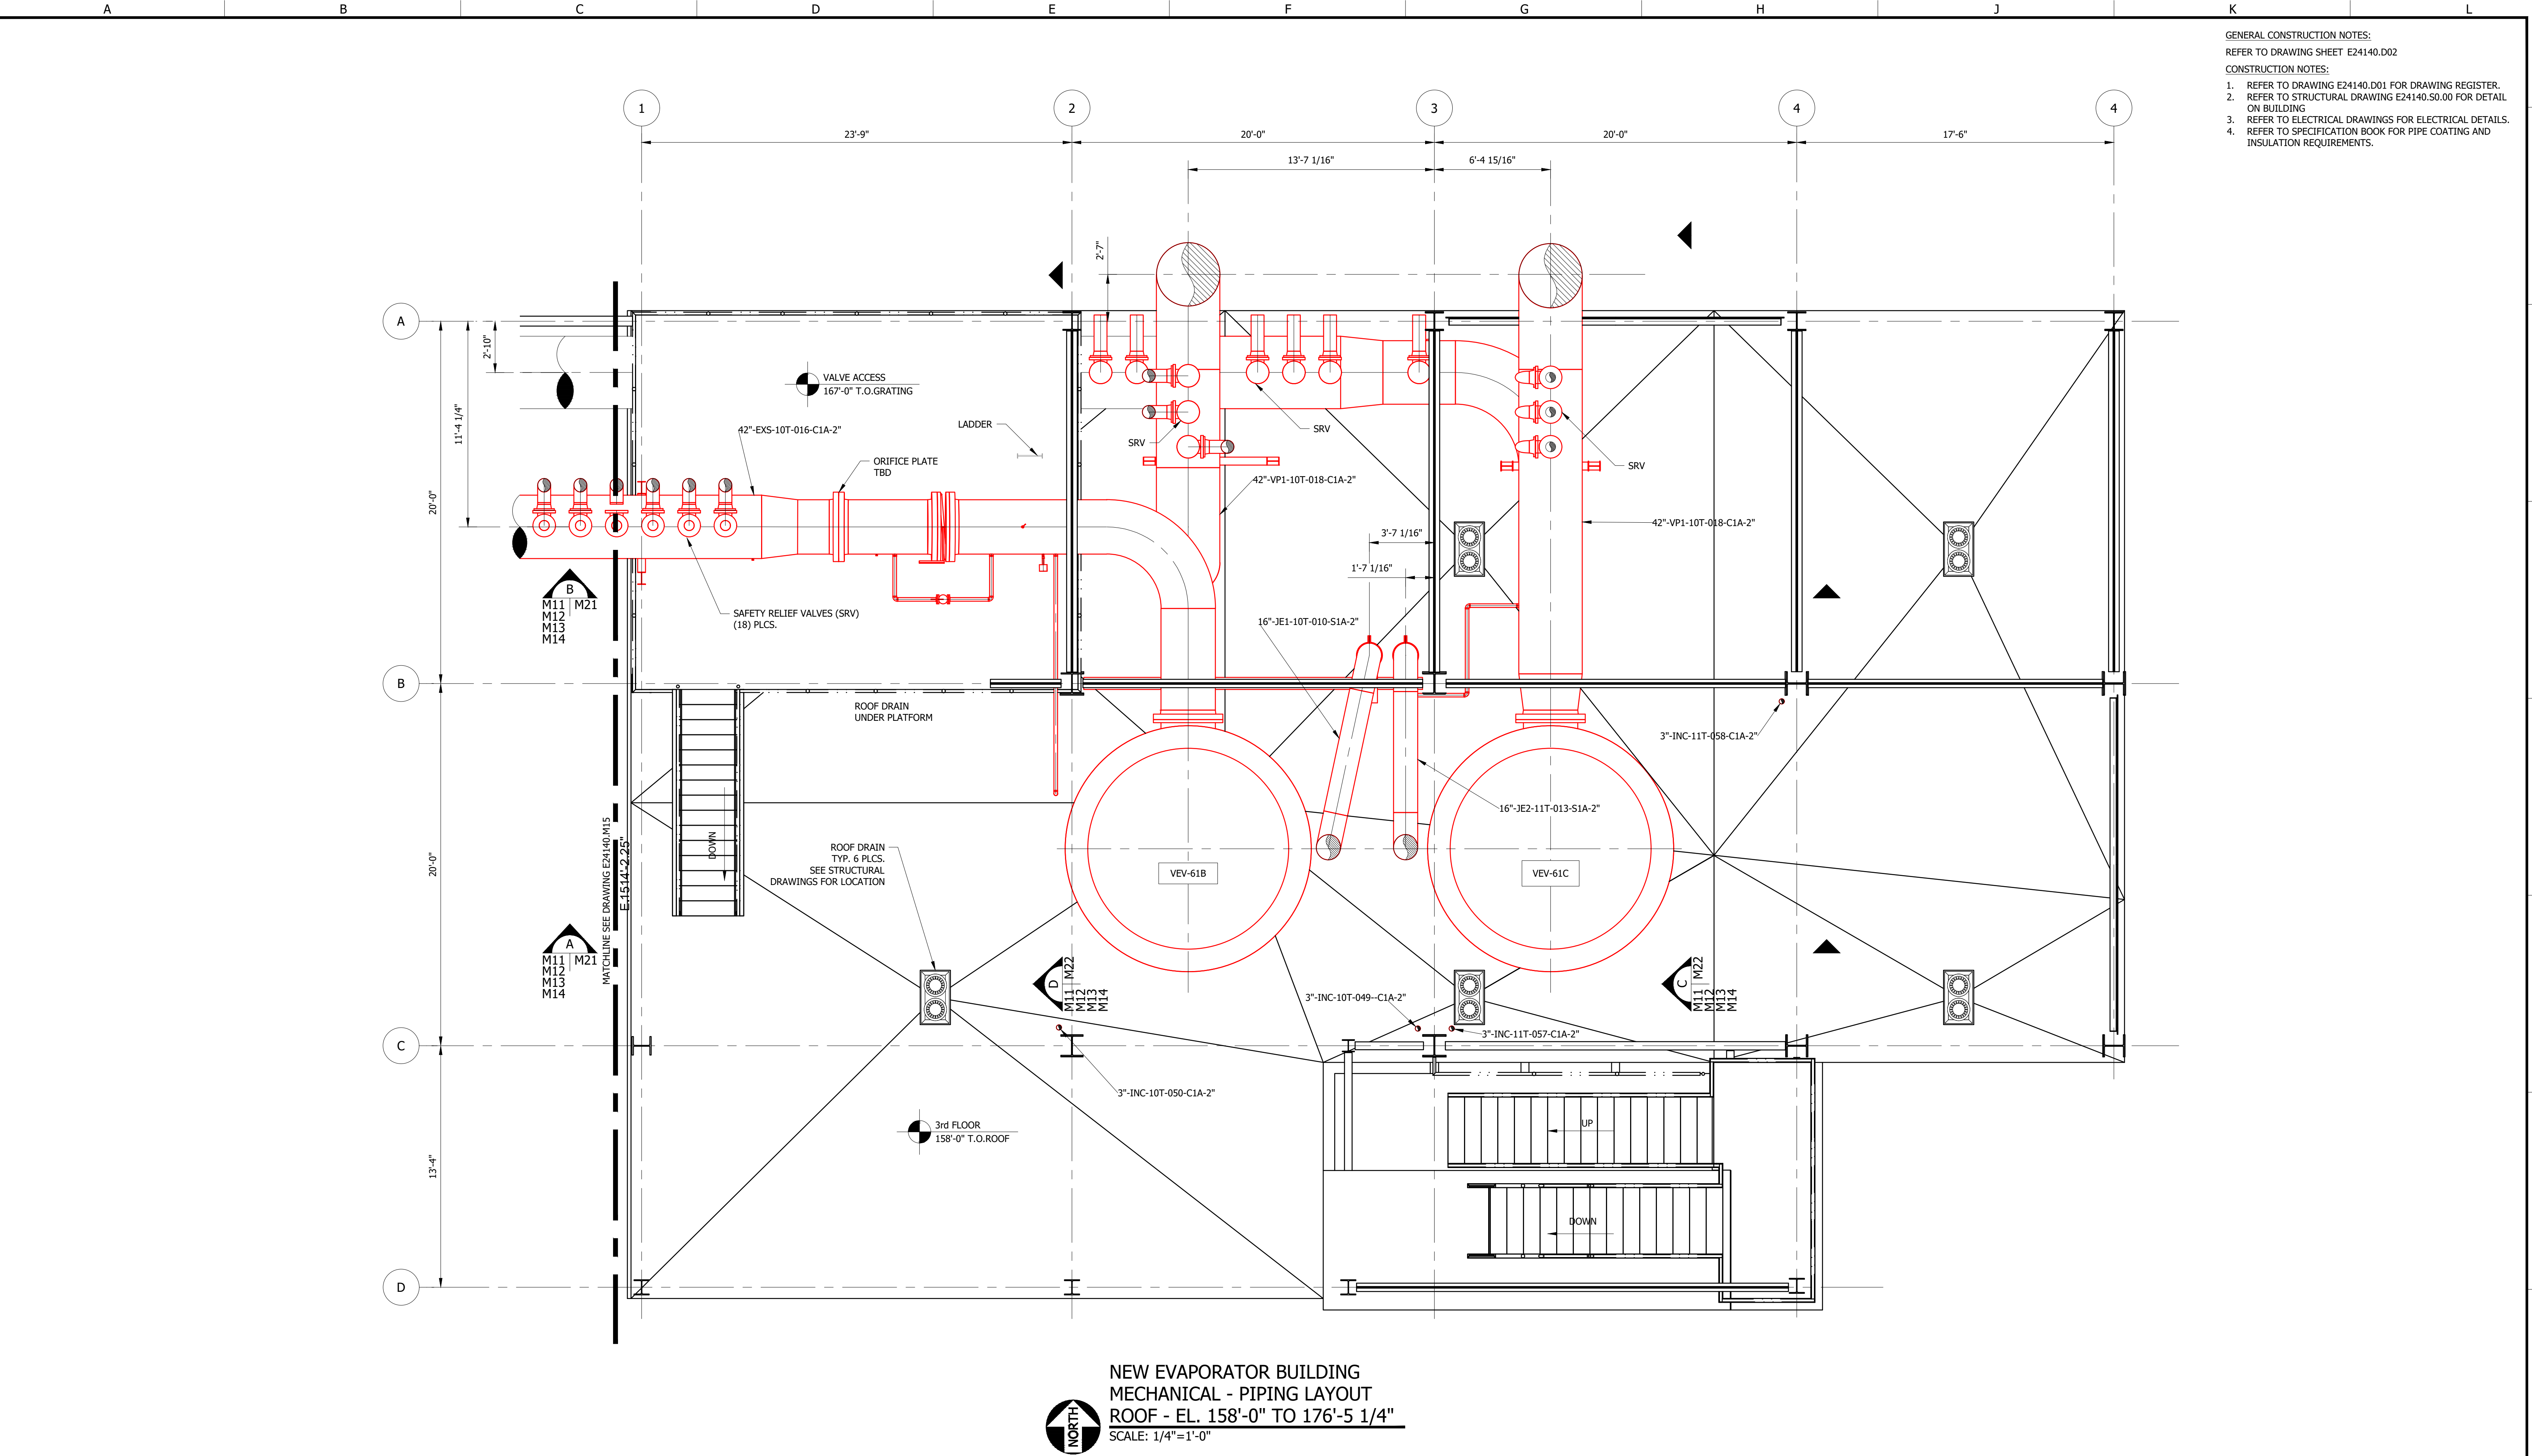

GENERAL CONSTRUCTION NOTES:
REFER TO DRAWING SHEET E24140.D02

CONSTRUCTION NOTES:

1. REFER TO DRAWING E24140.D01 FOR DRAWING REGISTER.
2. REFER TO STRUCTURAL DRAWING E24140.S0.00 FOR DETAIL ON BUILDING
3. REFER TO ELECTRICAL DRAWINGS FOR ELECTRICAL DETAILS.
4. REFER TO SPECIFICATION BOOK FOR PIPE COATING AND INSULATION REQUIREMENTS.

NEW EVAPORATOR BUILDING
MECHANICAL - PIPING LAYOUT
ROOF - EL. 158'-0" TO 176'-5 1/4"
SCALE: 1/4"=1'-0"

LINE LEGEND

NEW ———

EXIST ———

No.	Date	By	Revision
C	2025.07.02	MLW	ADDENDUM 1
B	2025.06.23	MLW	ISSUE FOR BID
A	2025.05.16	MLW	ISSUE FOR APPROVAL

PRELIMINARY
NOT FOR
CONSTRUCTION
2025.06.23

VEI Project No: E24140

One Galleria Blvd, Suite 1900
Metairie, LA 70001
Ph: 917.822.7982
www.veiglobal.com

VEI
ENGINEERING
GLOBAL

Title: AMALGAMATED SUGAR COMPANY THIN JUICE EVAPORATOR PROJECT MECHANICAL PIPING LAYOUT 3rd FLOOR		Date: 2025.05.08 Chkd By: SC Dsgn By: MLW	Dwg Set: 24/36
AMALGAMATED SUGAR COMPANY 2320 ORCHARD DRIVE EAST TWIN FALLS, IDAHO 83301		Project: E24140 Dwg: M13	Revision: